

NEPTUNE THEATRE ELECTRICS FLOOR PLAN 1/2" = 1'-0"




**-KEY-**

6	6x9 LEXO
13	8x12 LEXO
21	8" FRESNEL
20	6" FRESNEL 750w.
5	6" PARALLIPSPHERE
	EFFECTS PROJ.
X/Y	X=INST.# Y=DIMMER#

LIGHTING PLOT  
 'MIDEA'  
 NEPTUNE THEATRE FEB '81  
 DRAWN - DAVE TOSTI-LANE FOR P. PERINA  
 SCALE - 1/2" = 1'-0"



NEPTUNE THEATRE ELECTRICS FLOOR PLAN 1/2" = 1'-0"

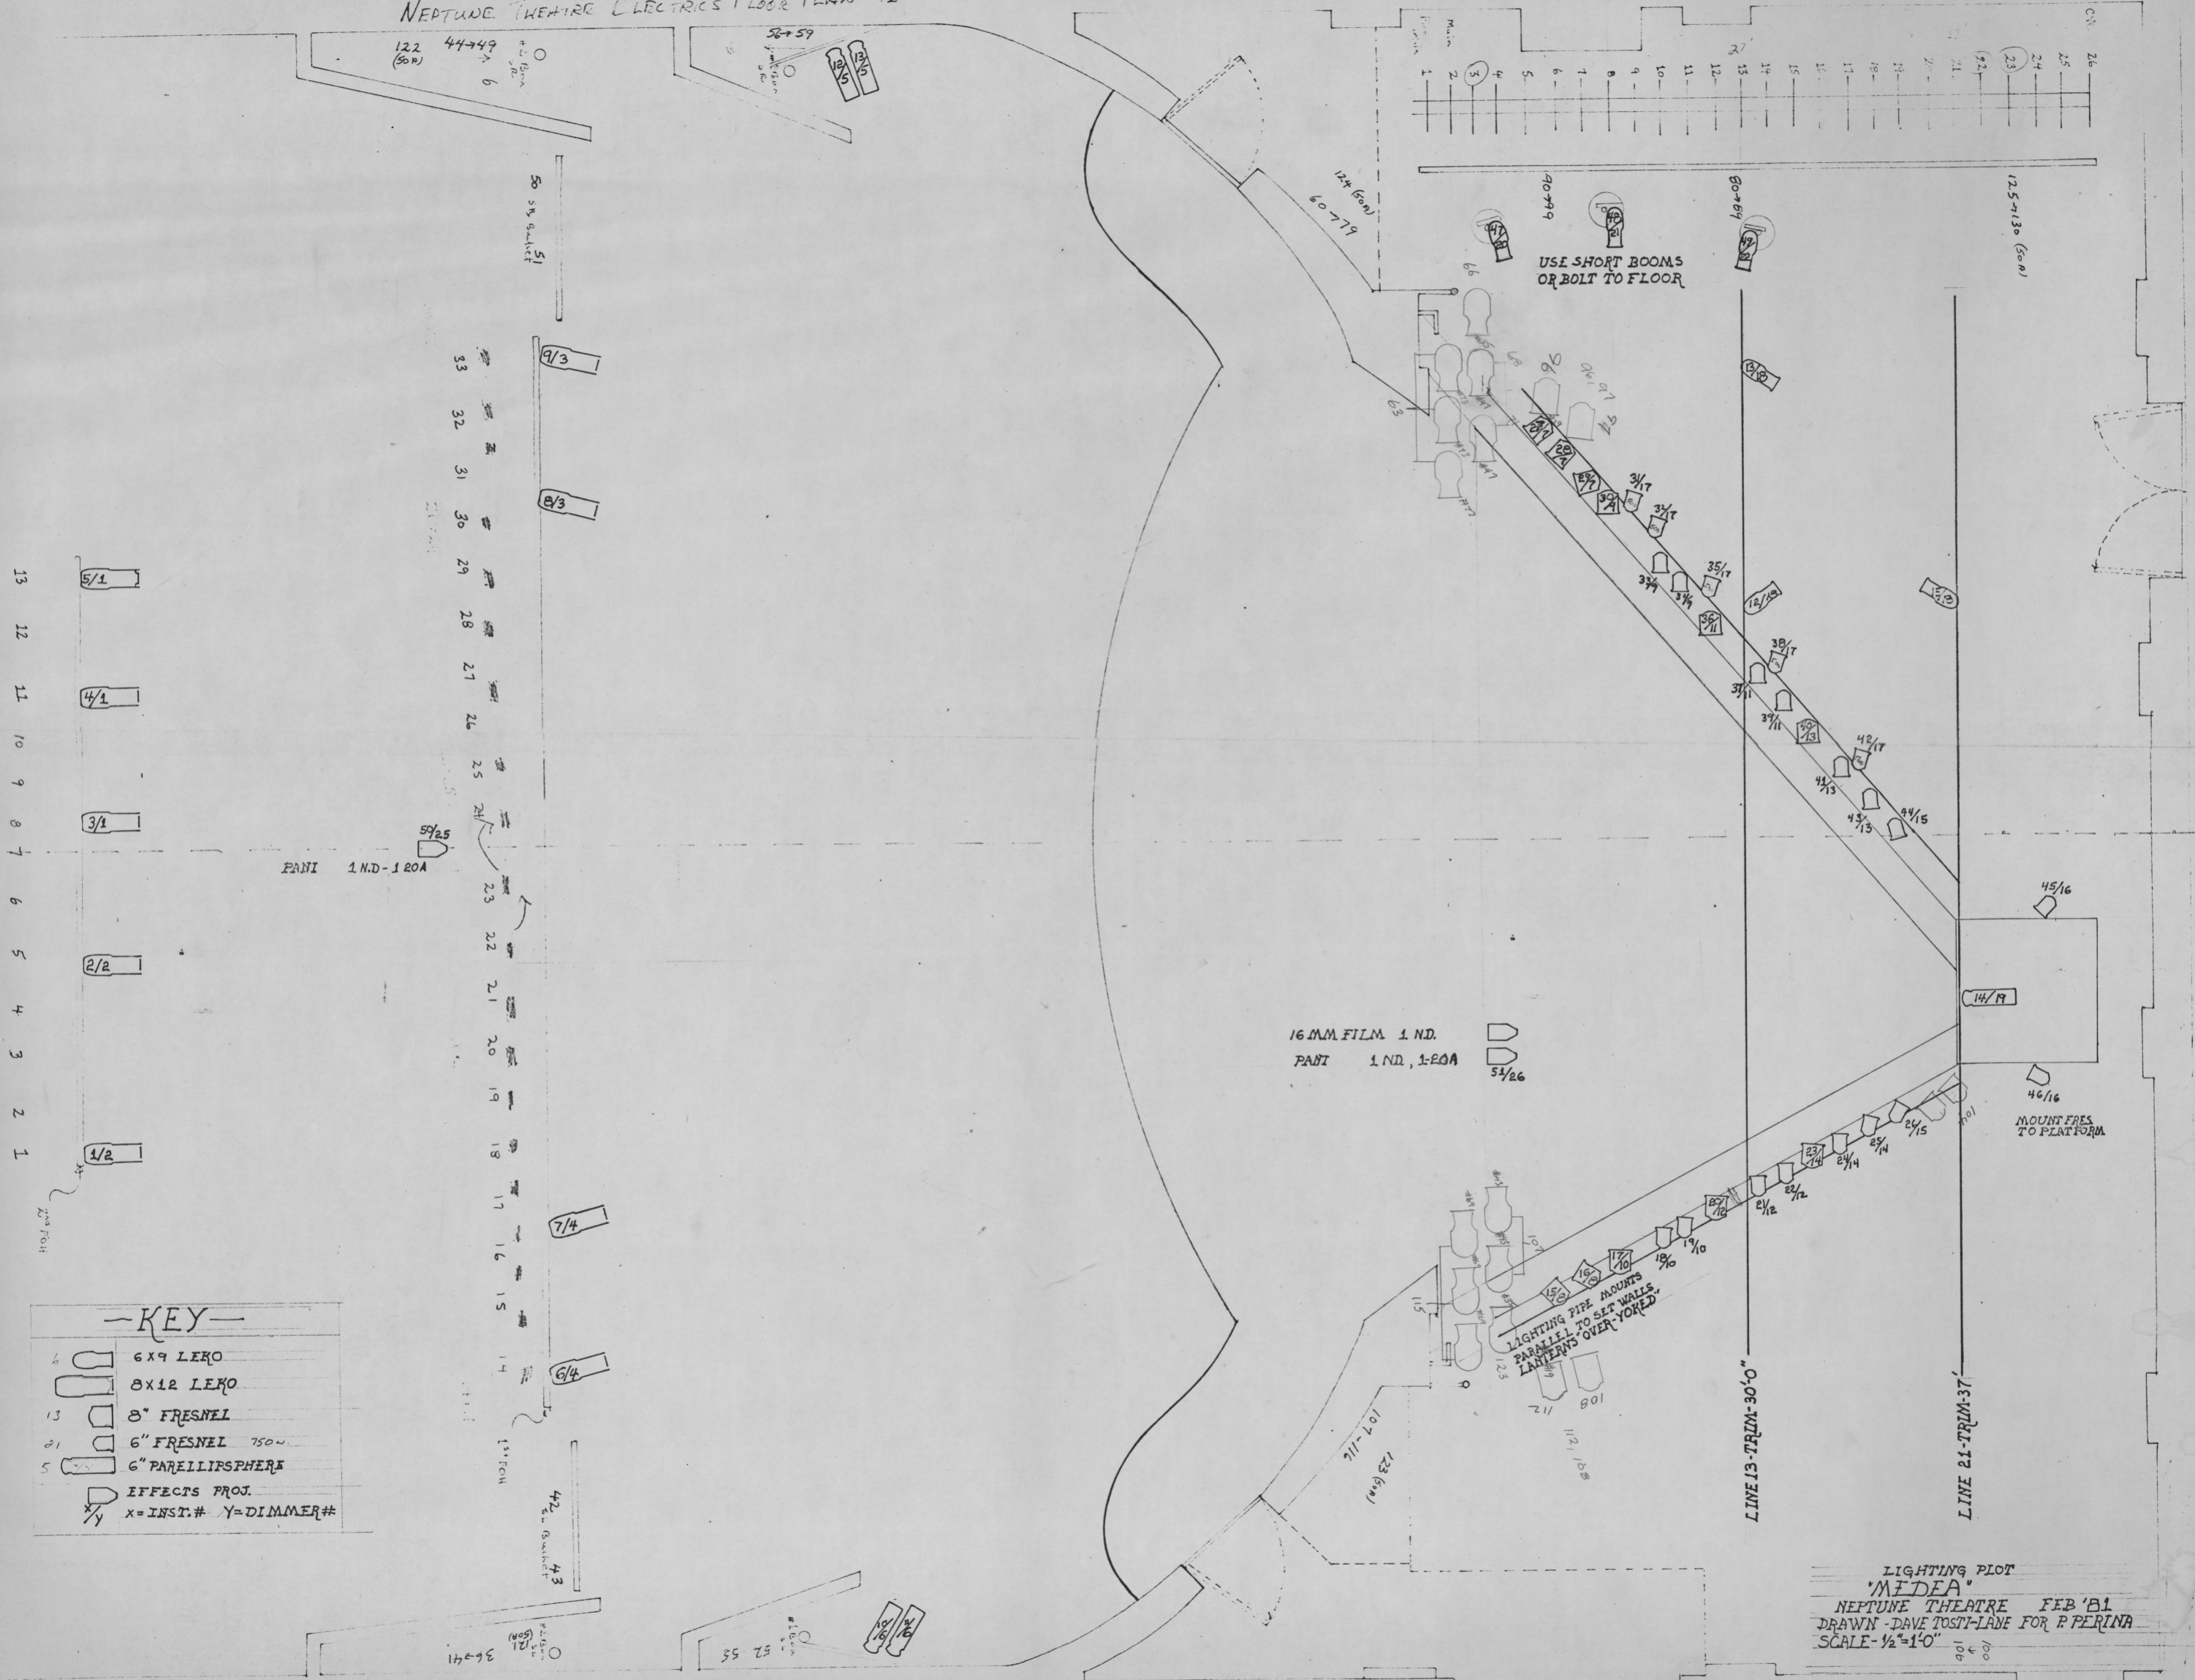

PANI 1 ND - 120A

16 MM FILM 1 ND.  
PANI 1 ND, 1-20A



LIGHTING PIPE MOUNTS  
PARALLEL TO SET WALLS  
LANTERNS OVER-YOKED


MOUNT FRES  
TO PLATFORM

**-KEY-**

6	6x9 LEKO
8	8x12 LEKO
13	8" FRESNEL
21	6" FRESNEL 750W
5	6" PARALLIPSPHERA
	EFFECTS PROJ.
X/Y	X=INST.# Y=DIMMER#

LIGHTING PLOT  
"MEDEA"  
NEPTUNE THEATRE FEB '81  
DRAWN - DAVE TOSTI-LANE FOR P. PERINA  
SCALE - 1/2" = 1'-0"




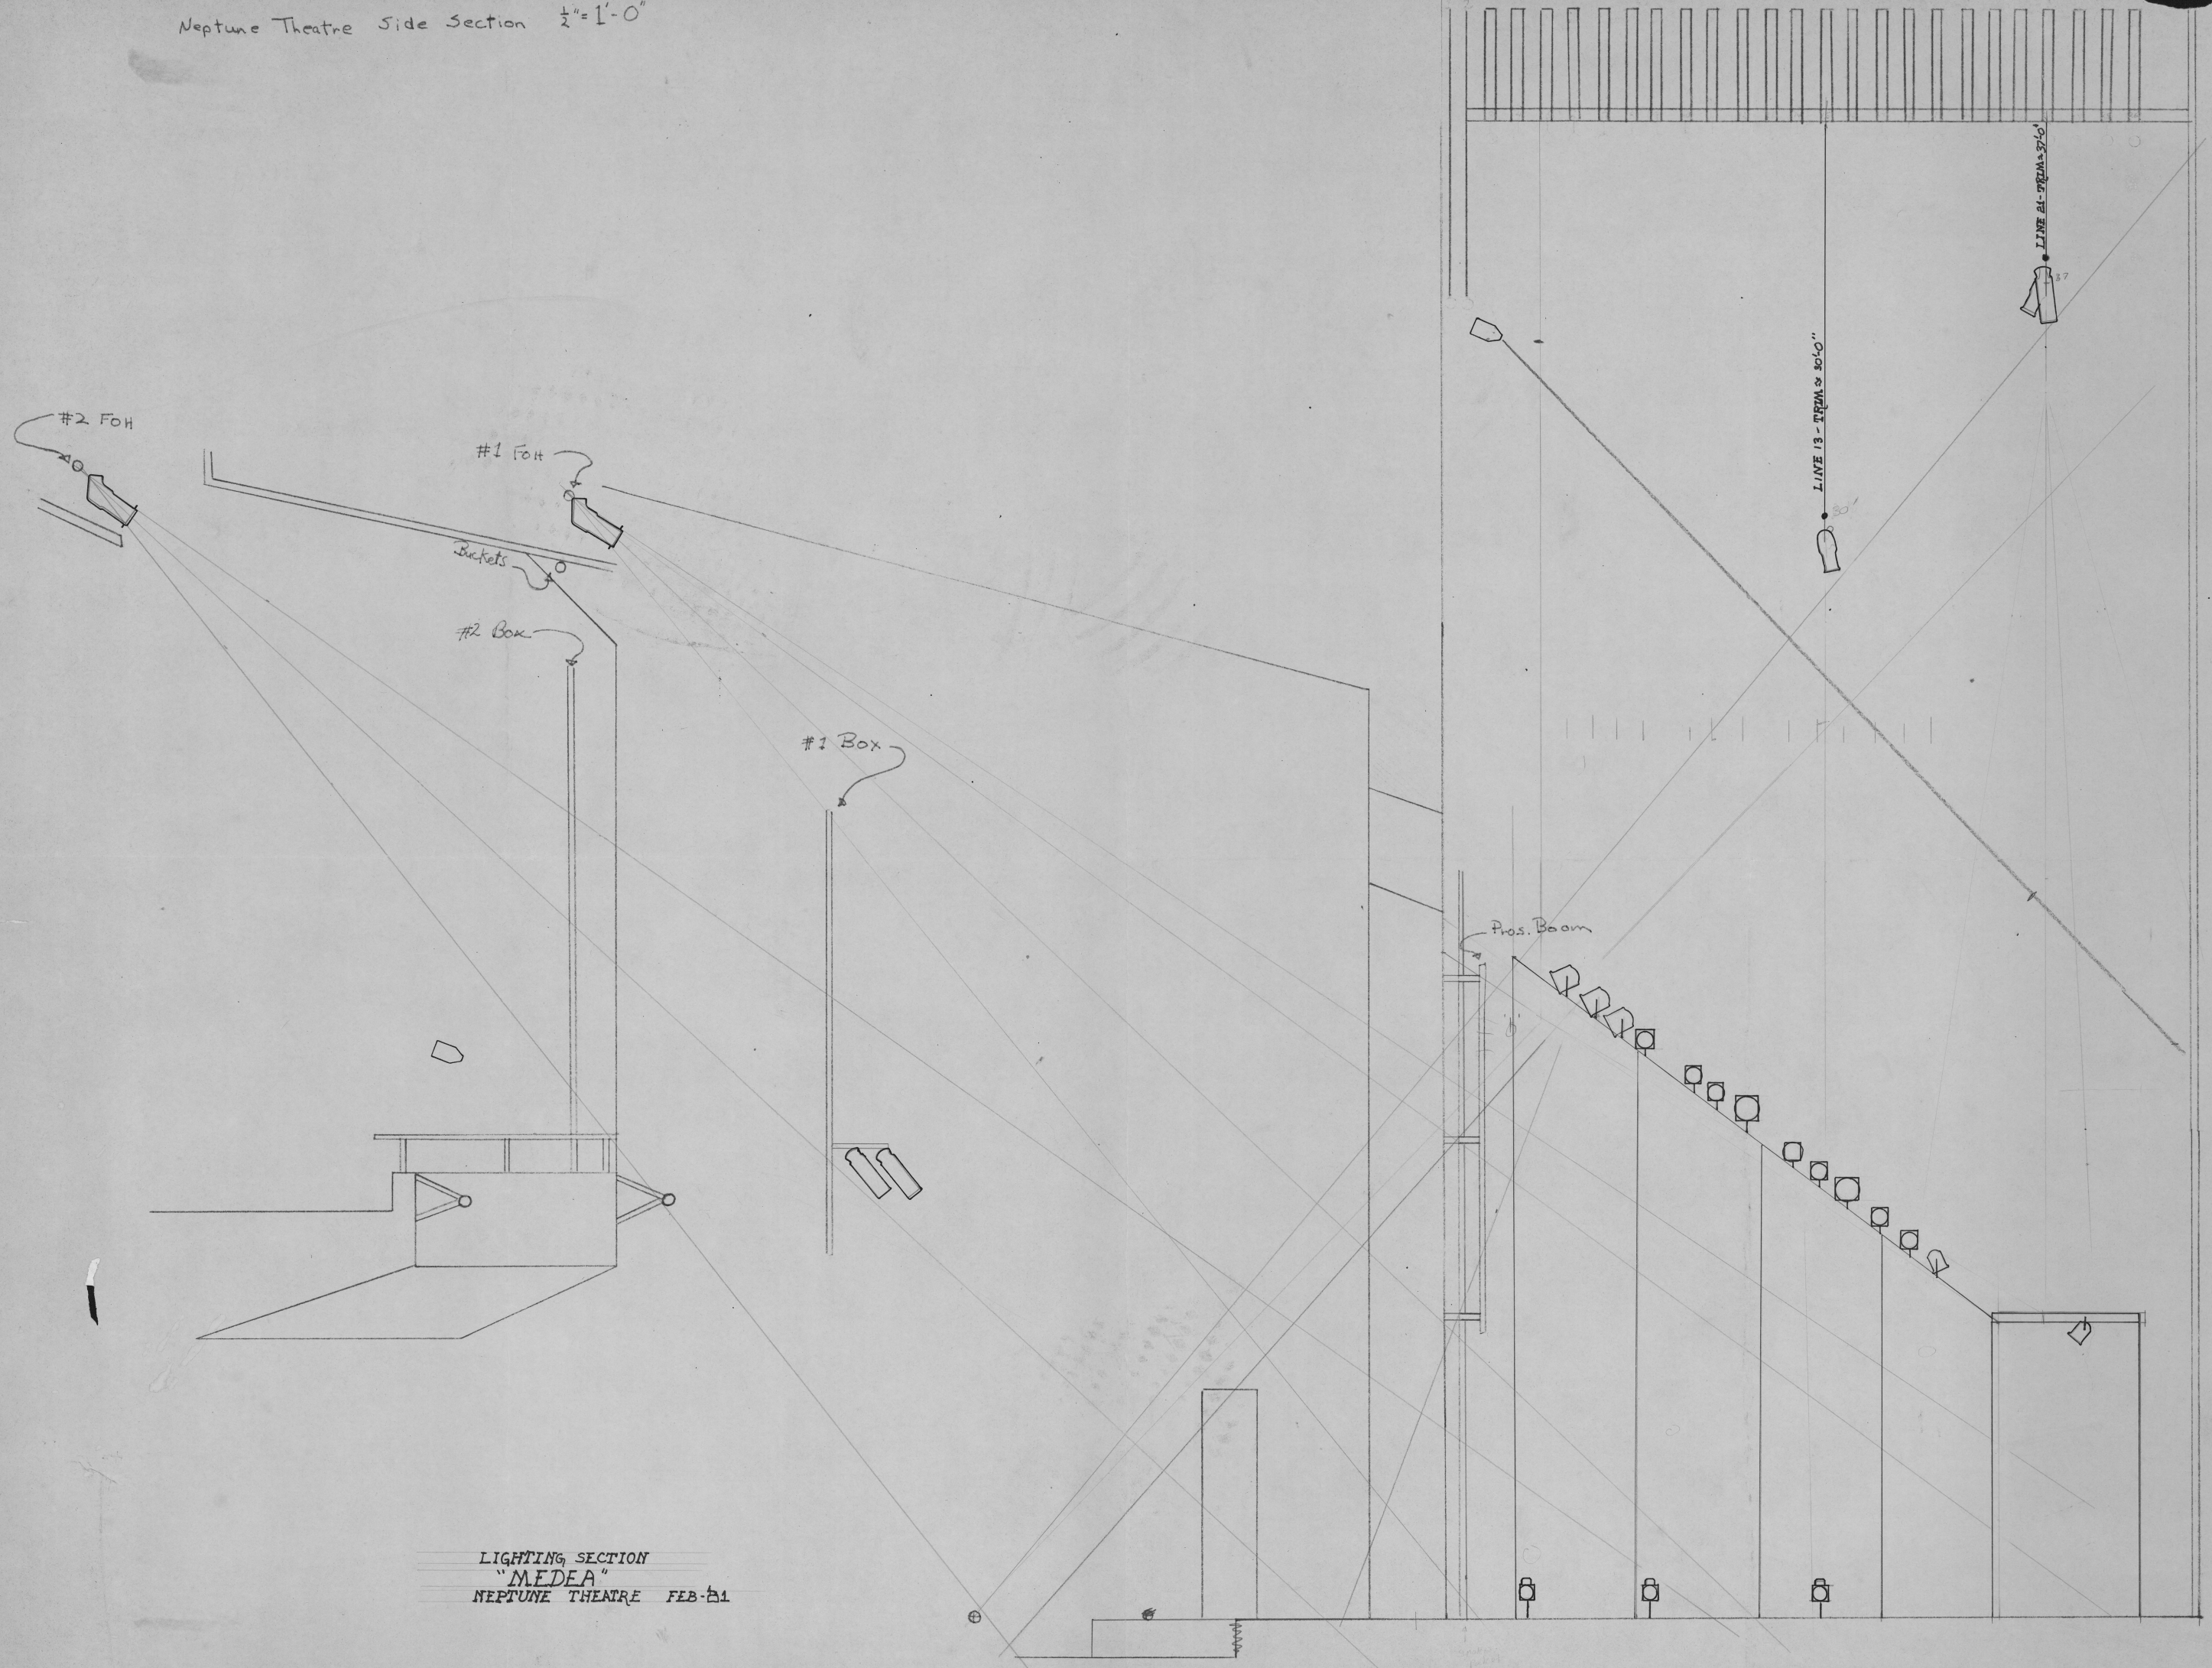

LIGHTING SECTION  
 "MEDEA"  
 NEPTUNE THEATRE FEB '21

241







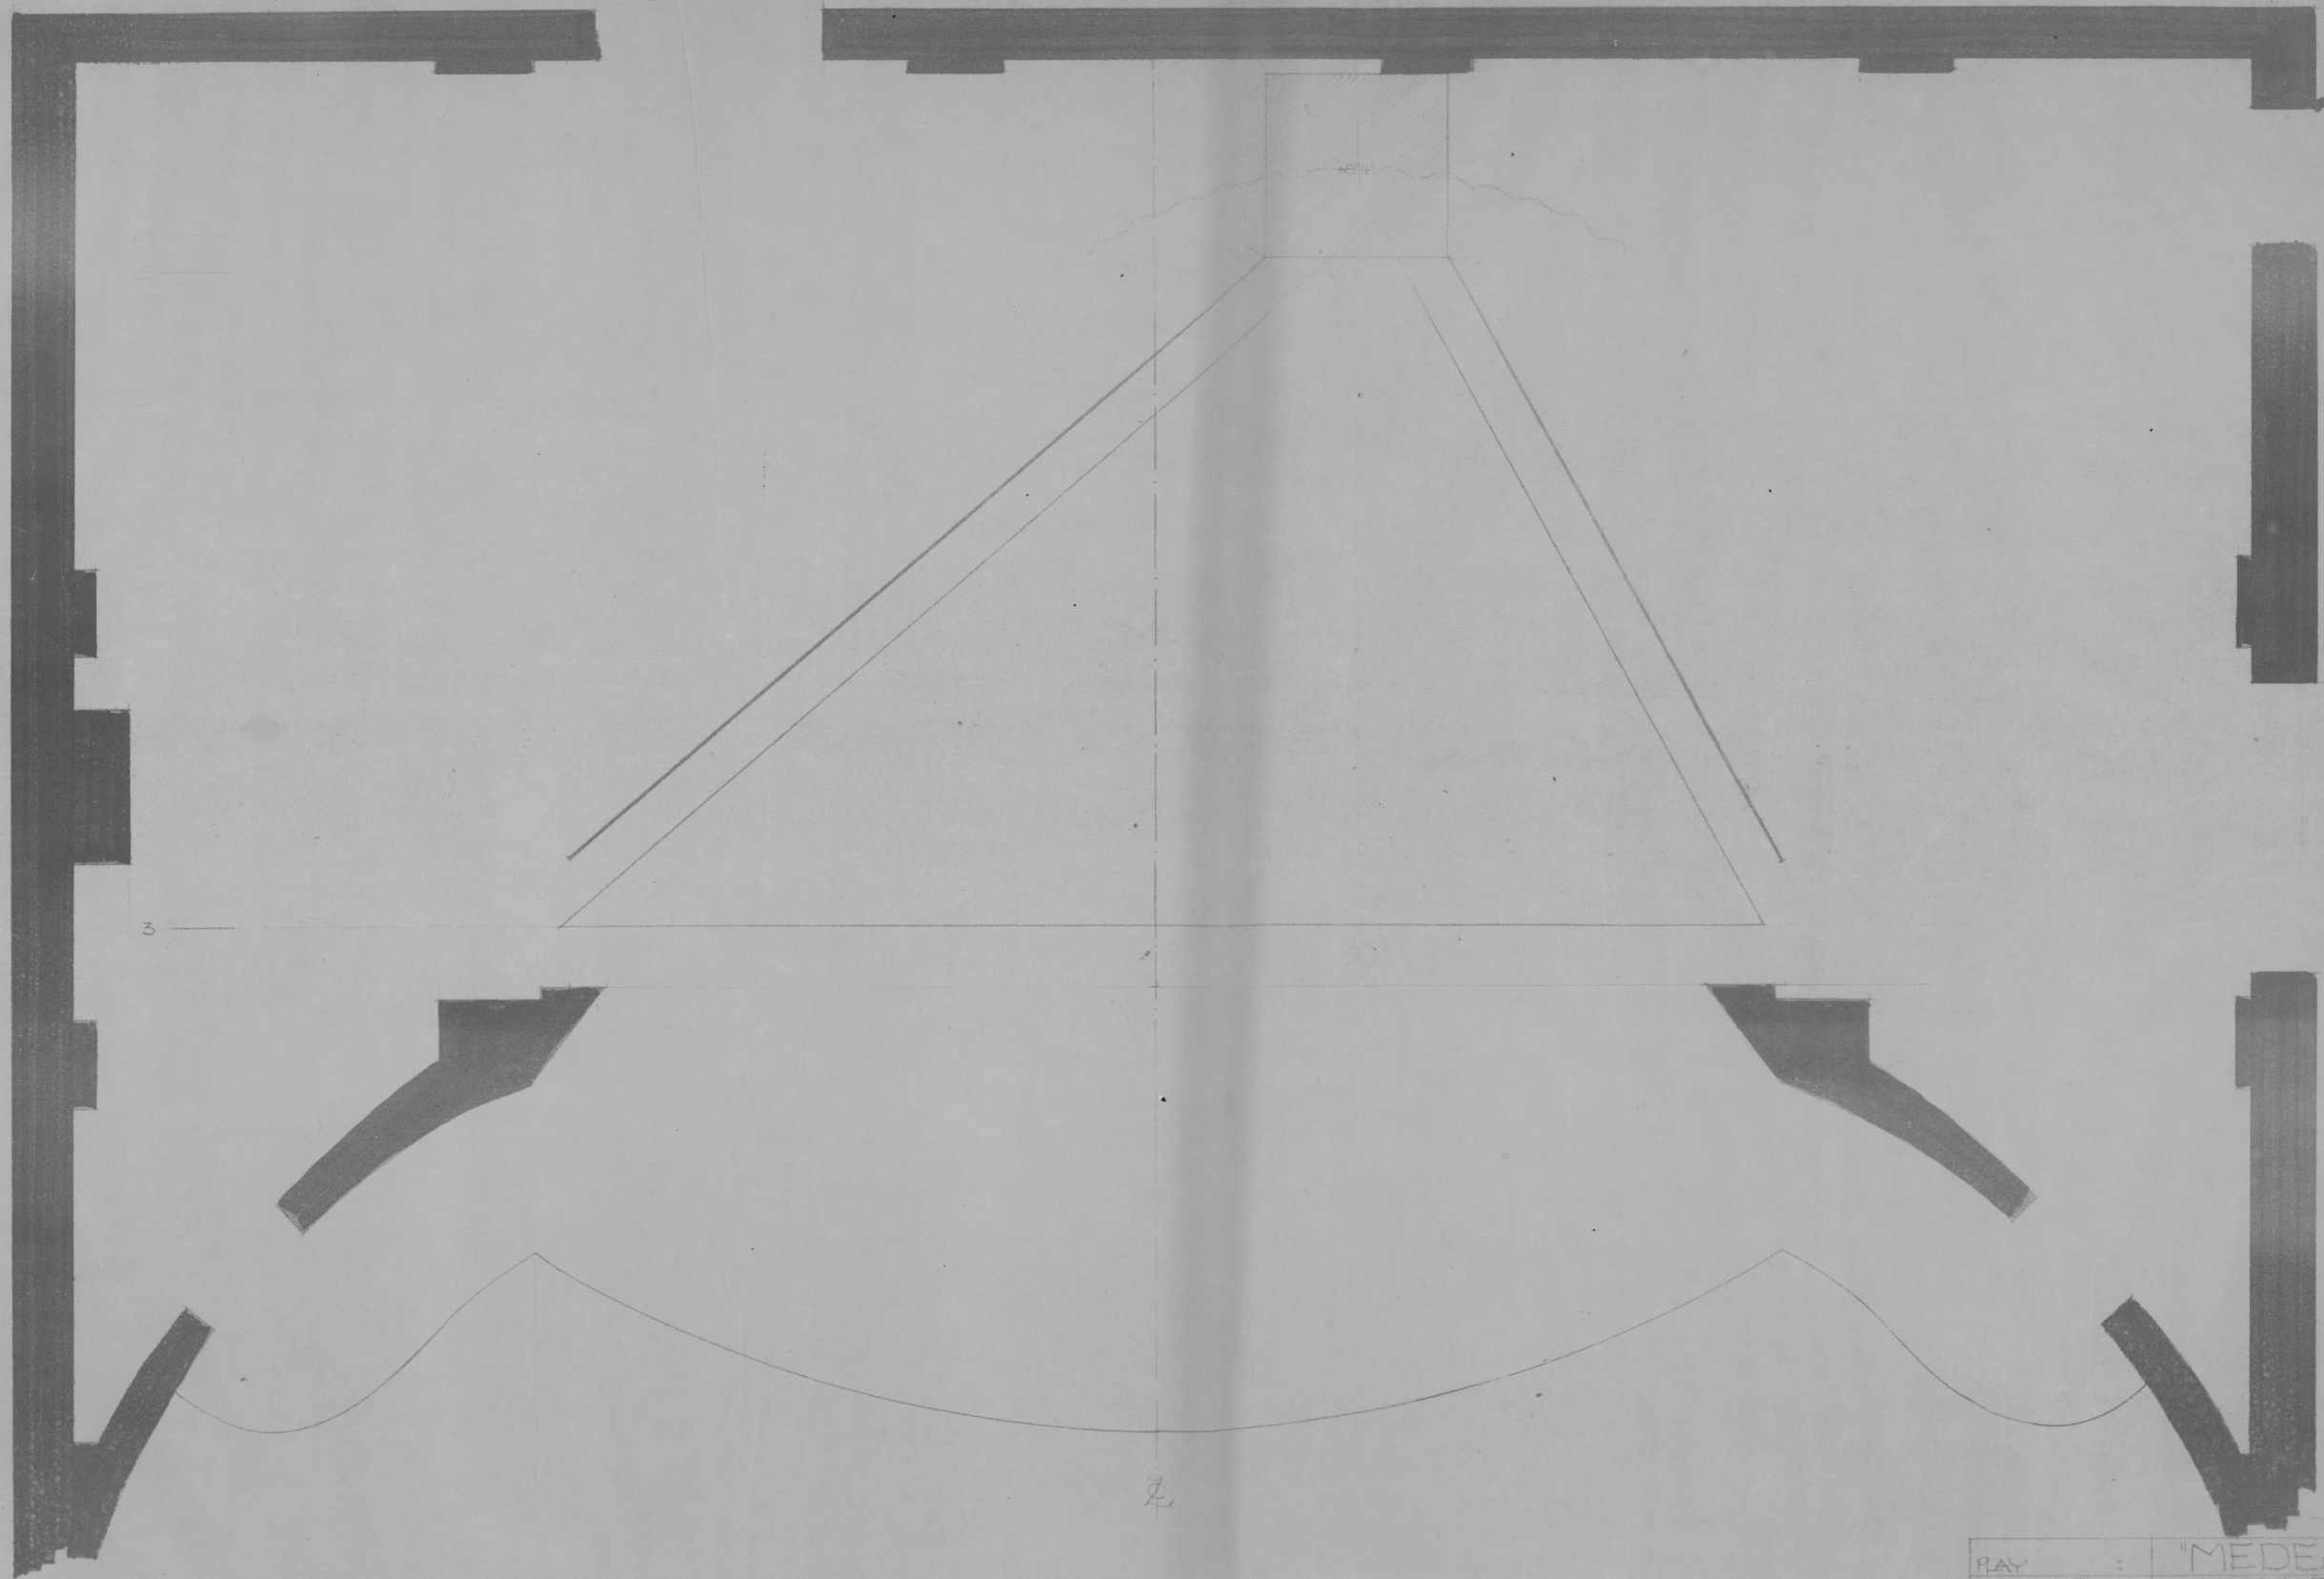

PLAY :	"MEDEA"	D.J.
DIRECTOR :	JOHN NEVILLE	
DESIGNER :	PETER PERINA	
DATE :	FEBRUARY 20TH 1981	
SCALE :	1/2" = 1'-0"	





SUGGESTED MATERIALS & CONSTRUCTION:  
 FOR CONSTRUCTION USE SQUARE TUBING 1/2" X 1/2" AND "L" SHAPED PROFILE 1/2" X 1/2".  
 TO THE DOWN ELASTICS STRIPS USE METAL STRIPS 1/2" X 1/8" AND SELF TAPPING SCREWS WITH WASHERS.  
 ELASTIC MATERIAL SHOULD BE STRETCHED BY 18" WITH ACCURATE CONSISTENCY.  
 STAGE RIG WALL STRIPS SHOULD BE 4" APART AND STAGE LEFT SHOULD BE SOLID.  
 TO SECURE WALLS USE FRENCH JACKS MADE OUT OF "L" SHAPED METAL PROFILES.  
 BACK PLATFORM SHOULD BE BUILT AFTER WALLS ARE SET IN PLACES.  
 FOR PLATFORM USE SIMPLE CONSTRUCTION OF 2x4 FRAME AND 3/4" PLY.  
 FOR ABOVE MENTIONED REFER TO THE SCALE MODEL.

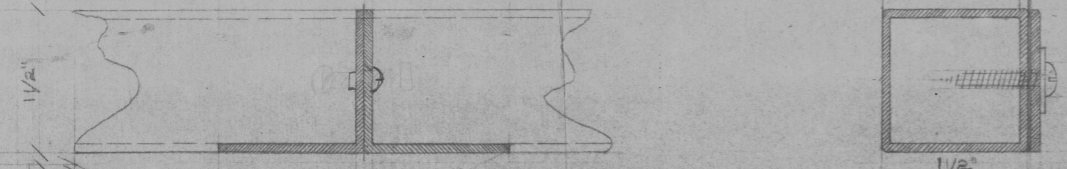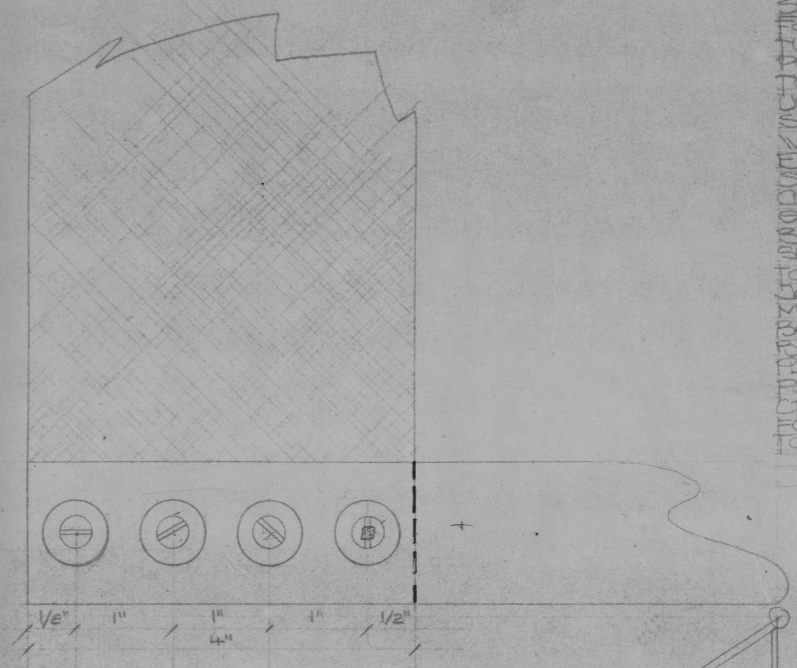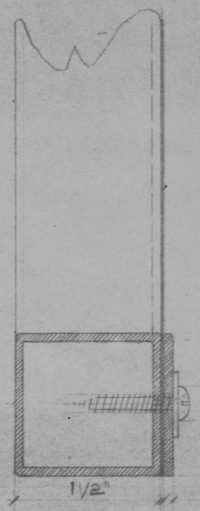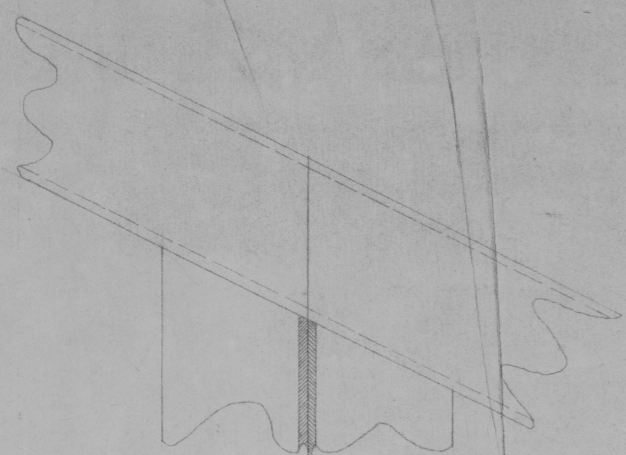

DETAIL A. SCALE 1"=1"


DETAIL B. SCALE 1"=1"

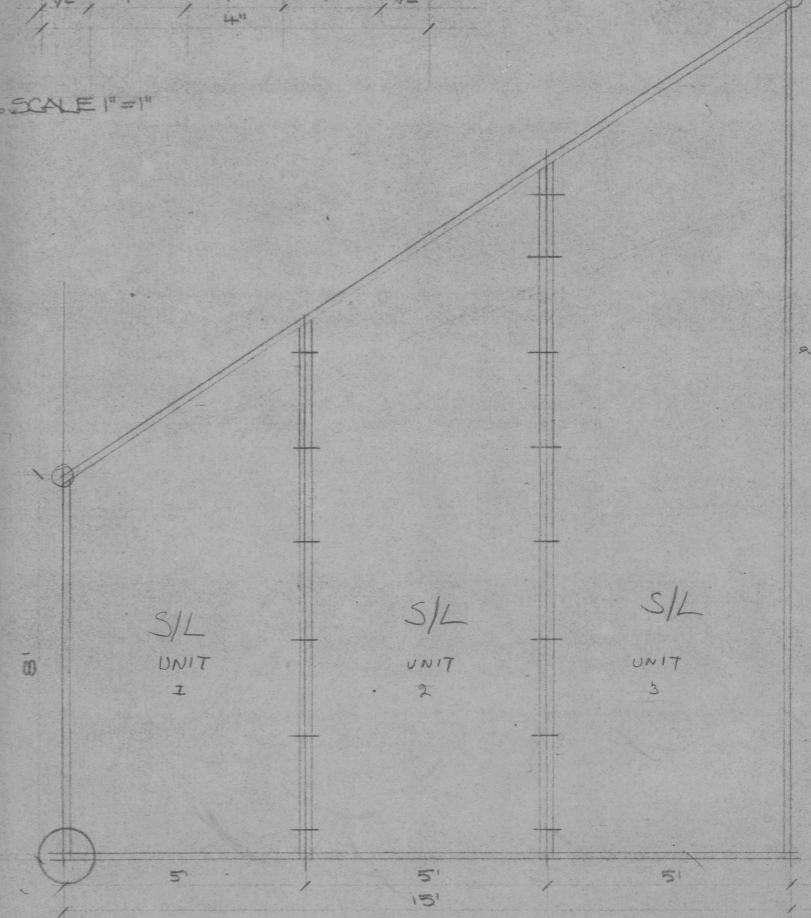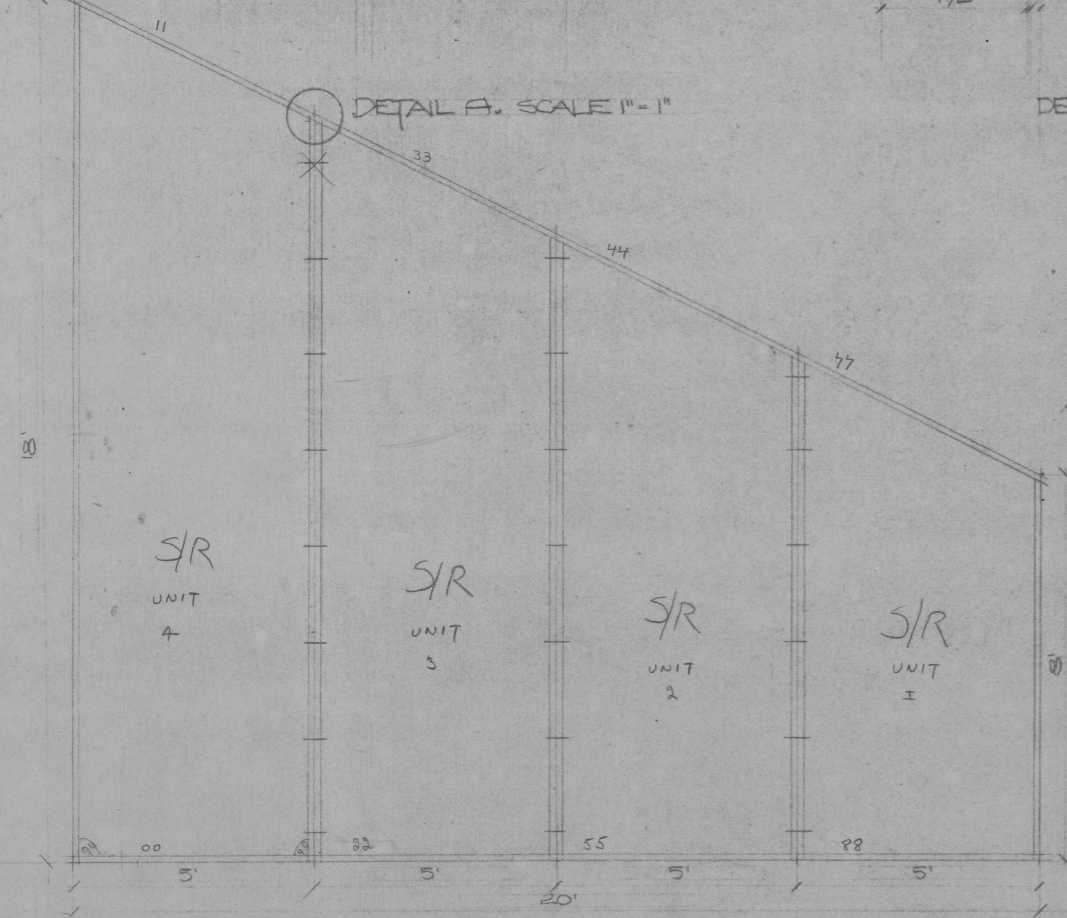

DETAIL B.


RAY	: MEDEA
DIRECTOR	: JOHN NEVILLE
DESIGNER	: PETER PERGAMO
DATE	: FEBRUARY 20, 81
SCALE	: 1/2" = 1'
USAL	: 1/2" = 1'



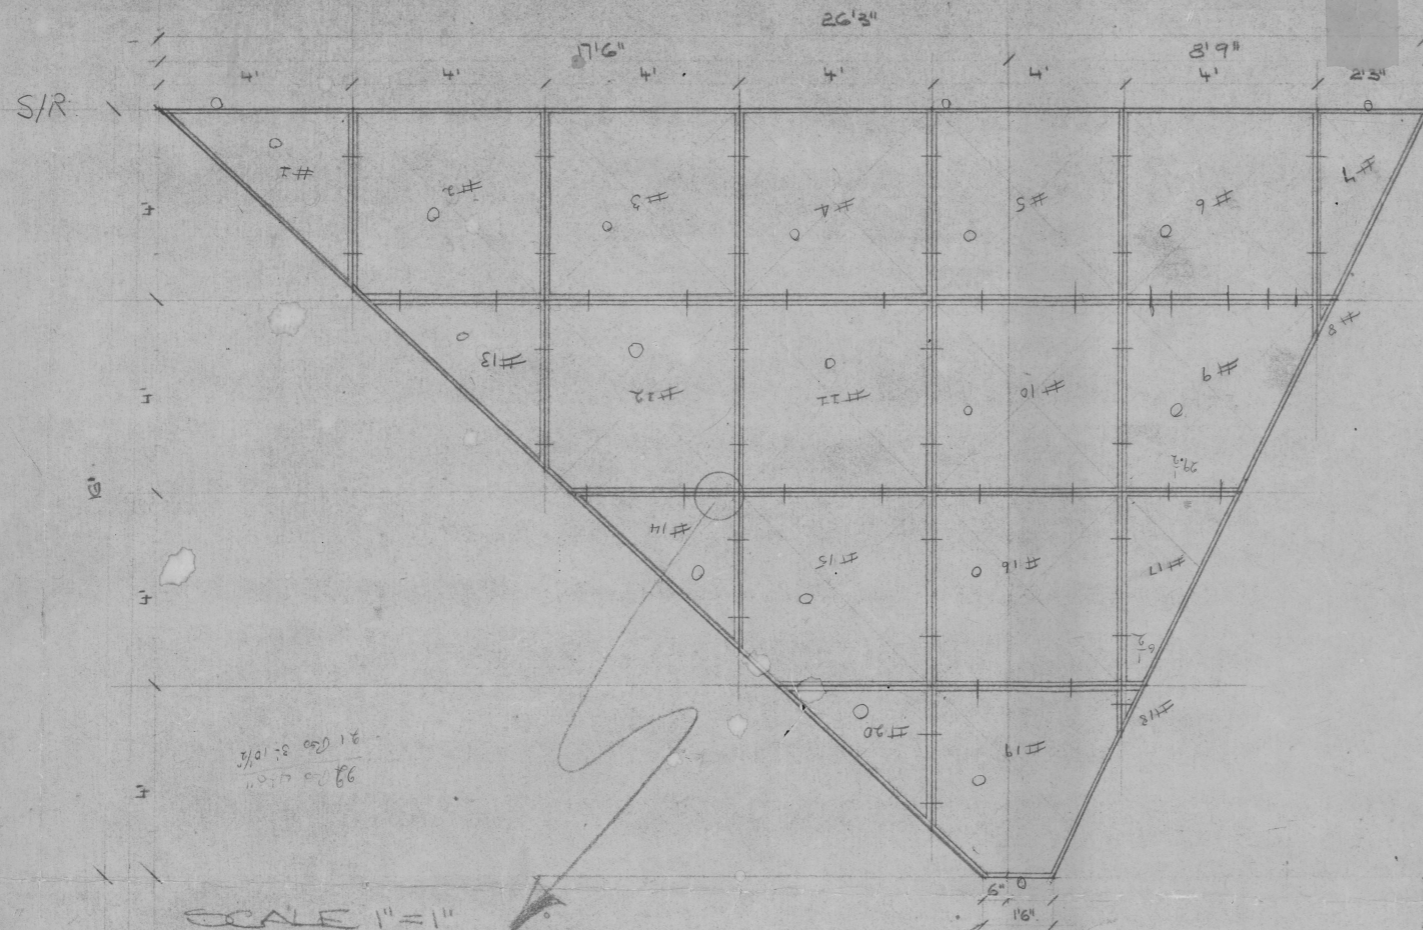

SCALE 1" = 1'

FOR CONSTRUCTION USE NO. 1 GRADE PINE 1x3.  
 ALL JOINTS ARE HALVED WITH 1/8" GROOVE.  
 USE 1/2" OF 3/4" SQUARES 2" APART.  
 TO JOIN THE PANELS USE 3/8" BOLTS.

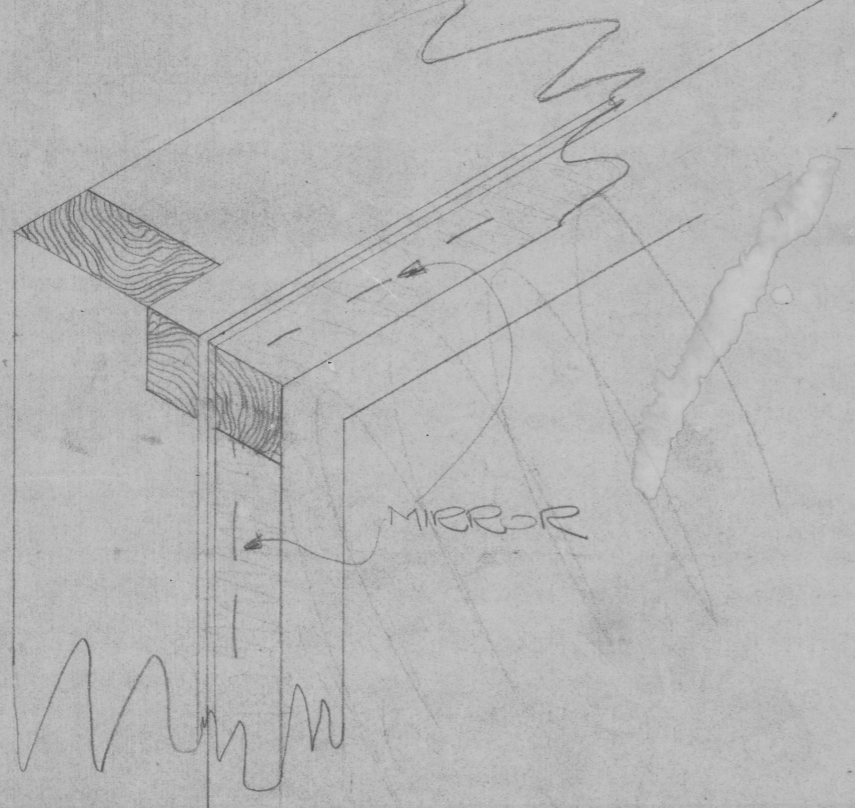

PLAY	NO.	"MEDEA"	12
DIRECTOR	NO.	JOHN NEVILLE	
DESIGNER	NO.	PETER FERNA	
DATE	NO.	FEBRUARY 20, 81.	
SCALE	NO.	1/2" = 1'	
DETAIL	NO.	1" = 1'	